


BILL OF MATERIAL

(Quantity shown for one installation)

ITEM	QTY	UNIT	DESCRIPTION	SIZE	MAT'L
1	6	M	TUBING, SEAMLESS	1/2" OD X 0.049" WT	316L SS
2	2	EA	MALE CONNECTOR	1/2" OD X 1/2" NPTM	316 SS

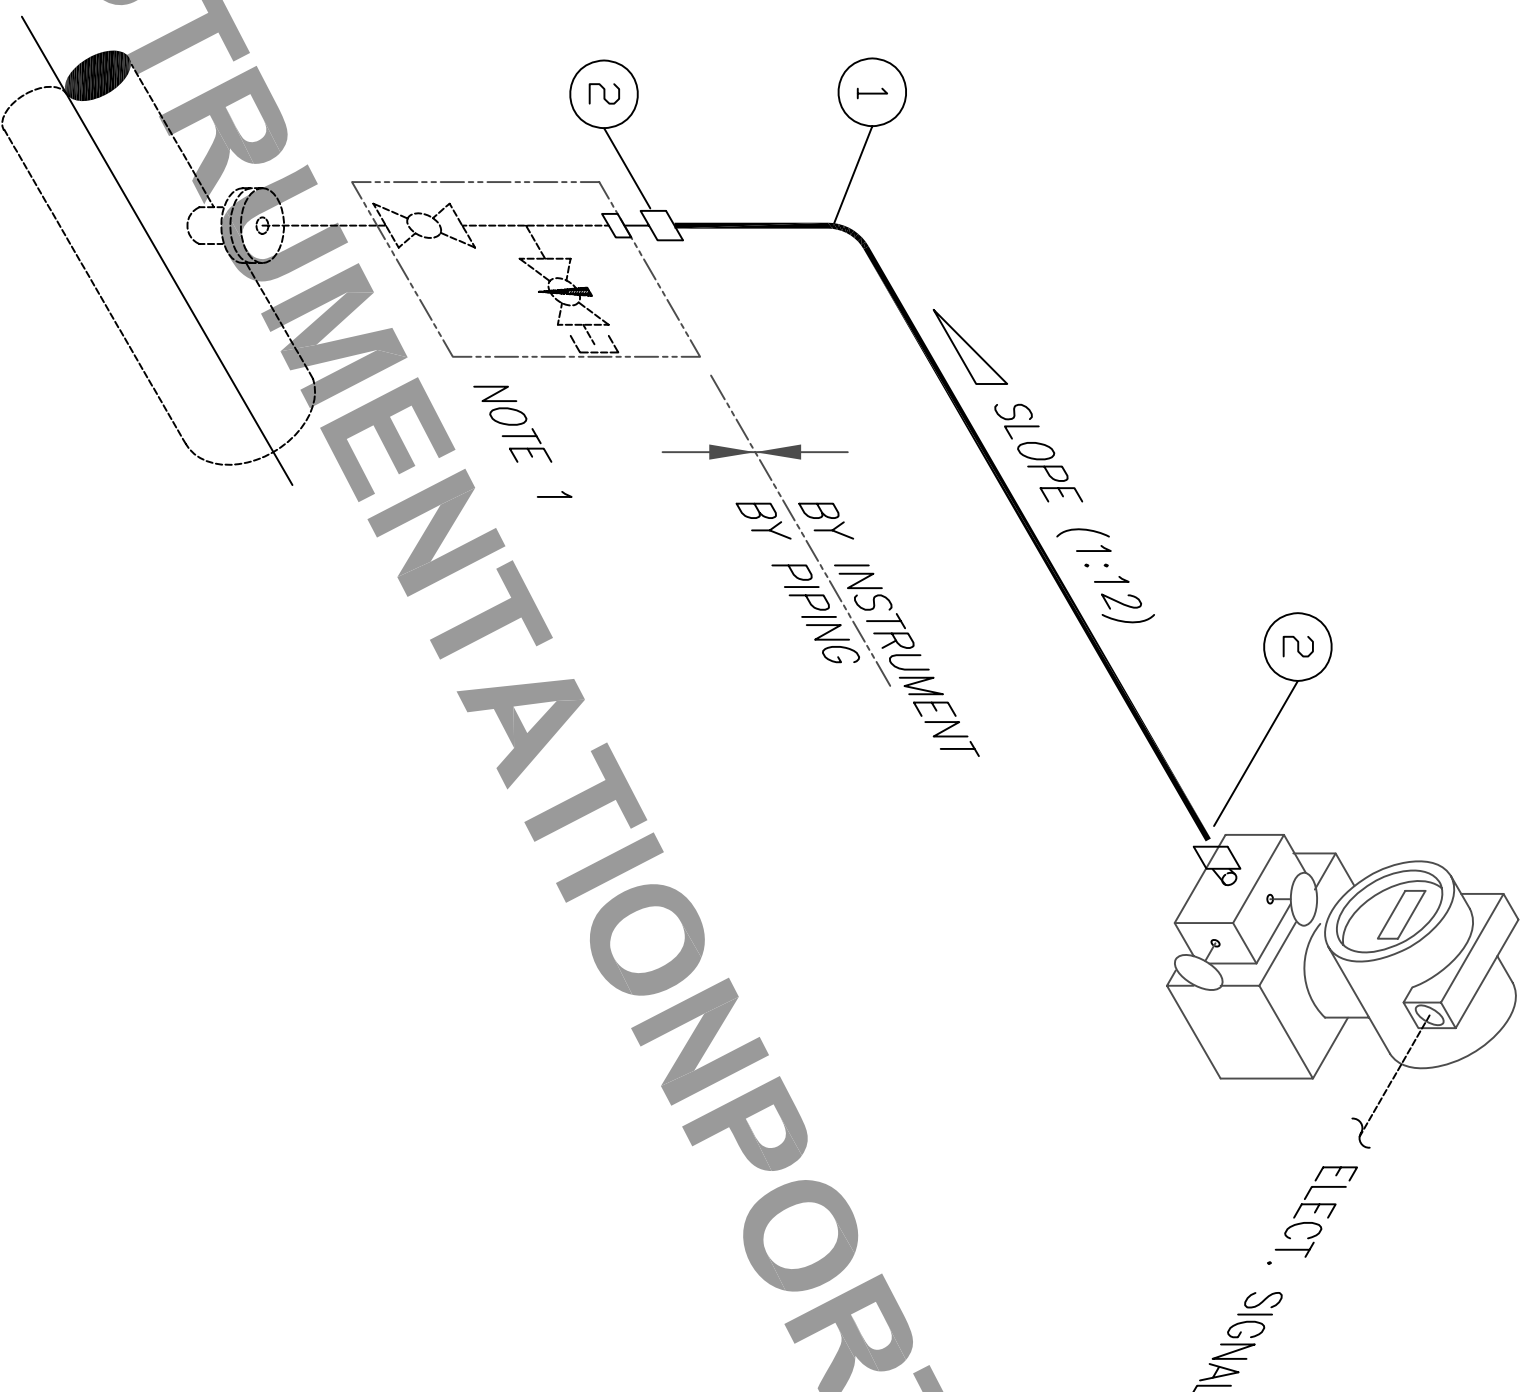

- NOTES :
- SINGLE BLOCK & BLEED INTEGRATED MANIFOLD SUPPLIED BY PIPING

APPLICATION

TAG NO.	P&ID NO.	TAG NO.	P&ID NO.
PIT-0100	P-CPP-PID-01-001	PIT-0200	P-CPP-PID-01-101
PIT-0101	P-CPP-PID-01-001	PIT-0201	P-CPP-PID-01-101

INSTRUMENTATION PORTAL.COM

REFERENCE DWG NO.	DATE	REV	DESCRIPTION	BY	CHK	ENG	LEAD	PM	L. ENG.	P.M.	CLIENT

PROJECT NAME: INSTRUMENTATION PORTAL.COM

DISCIPLINE: INSTRUMENT

SUB-SYSTEM: 00-GENERAL

DOCUMENT TYPE: BLOCK DIAGRAM

TITLE: PROCESS HOOK-UP DIAGRAM

SCALE: PRESSURE TRANSMITTER - GAS SERVICE

PROJECT NO./DWG NO.: NTS